



# PENTICTON AIRPORT AIRPORT ROAD FORCEMAIN REPLACEMENT

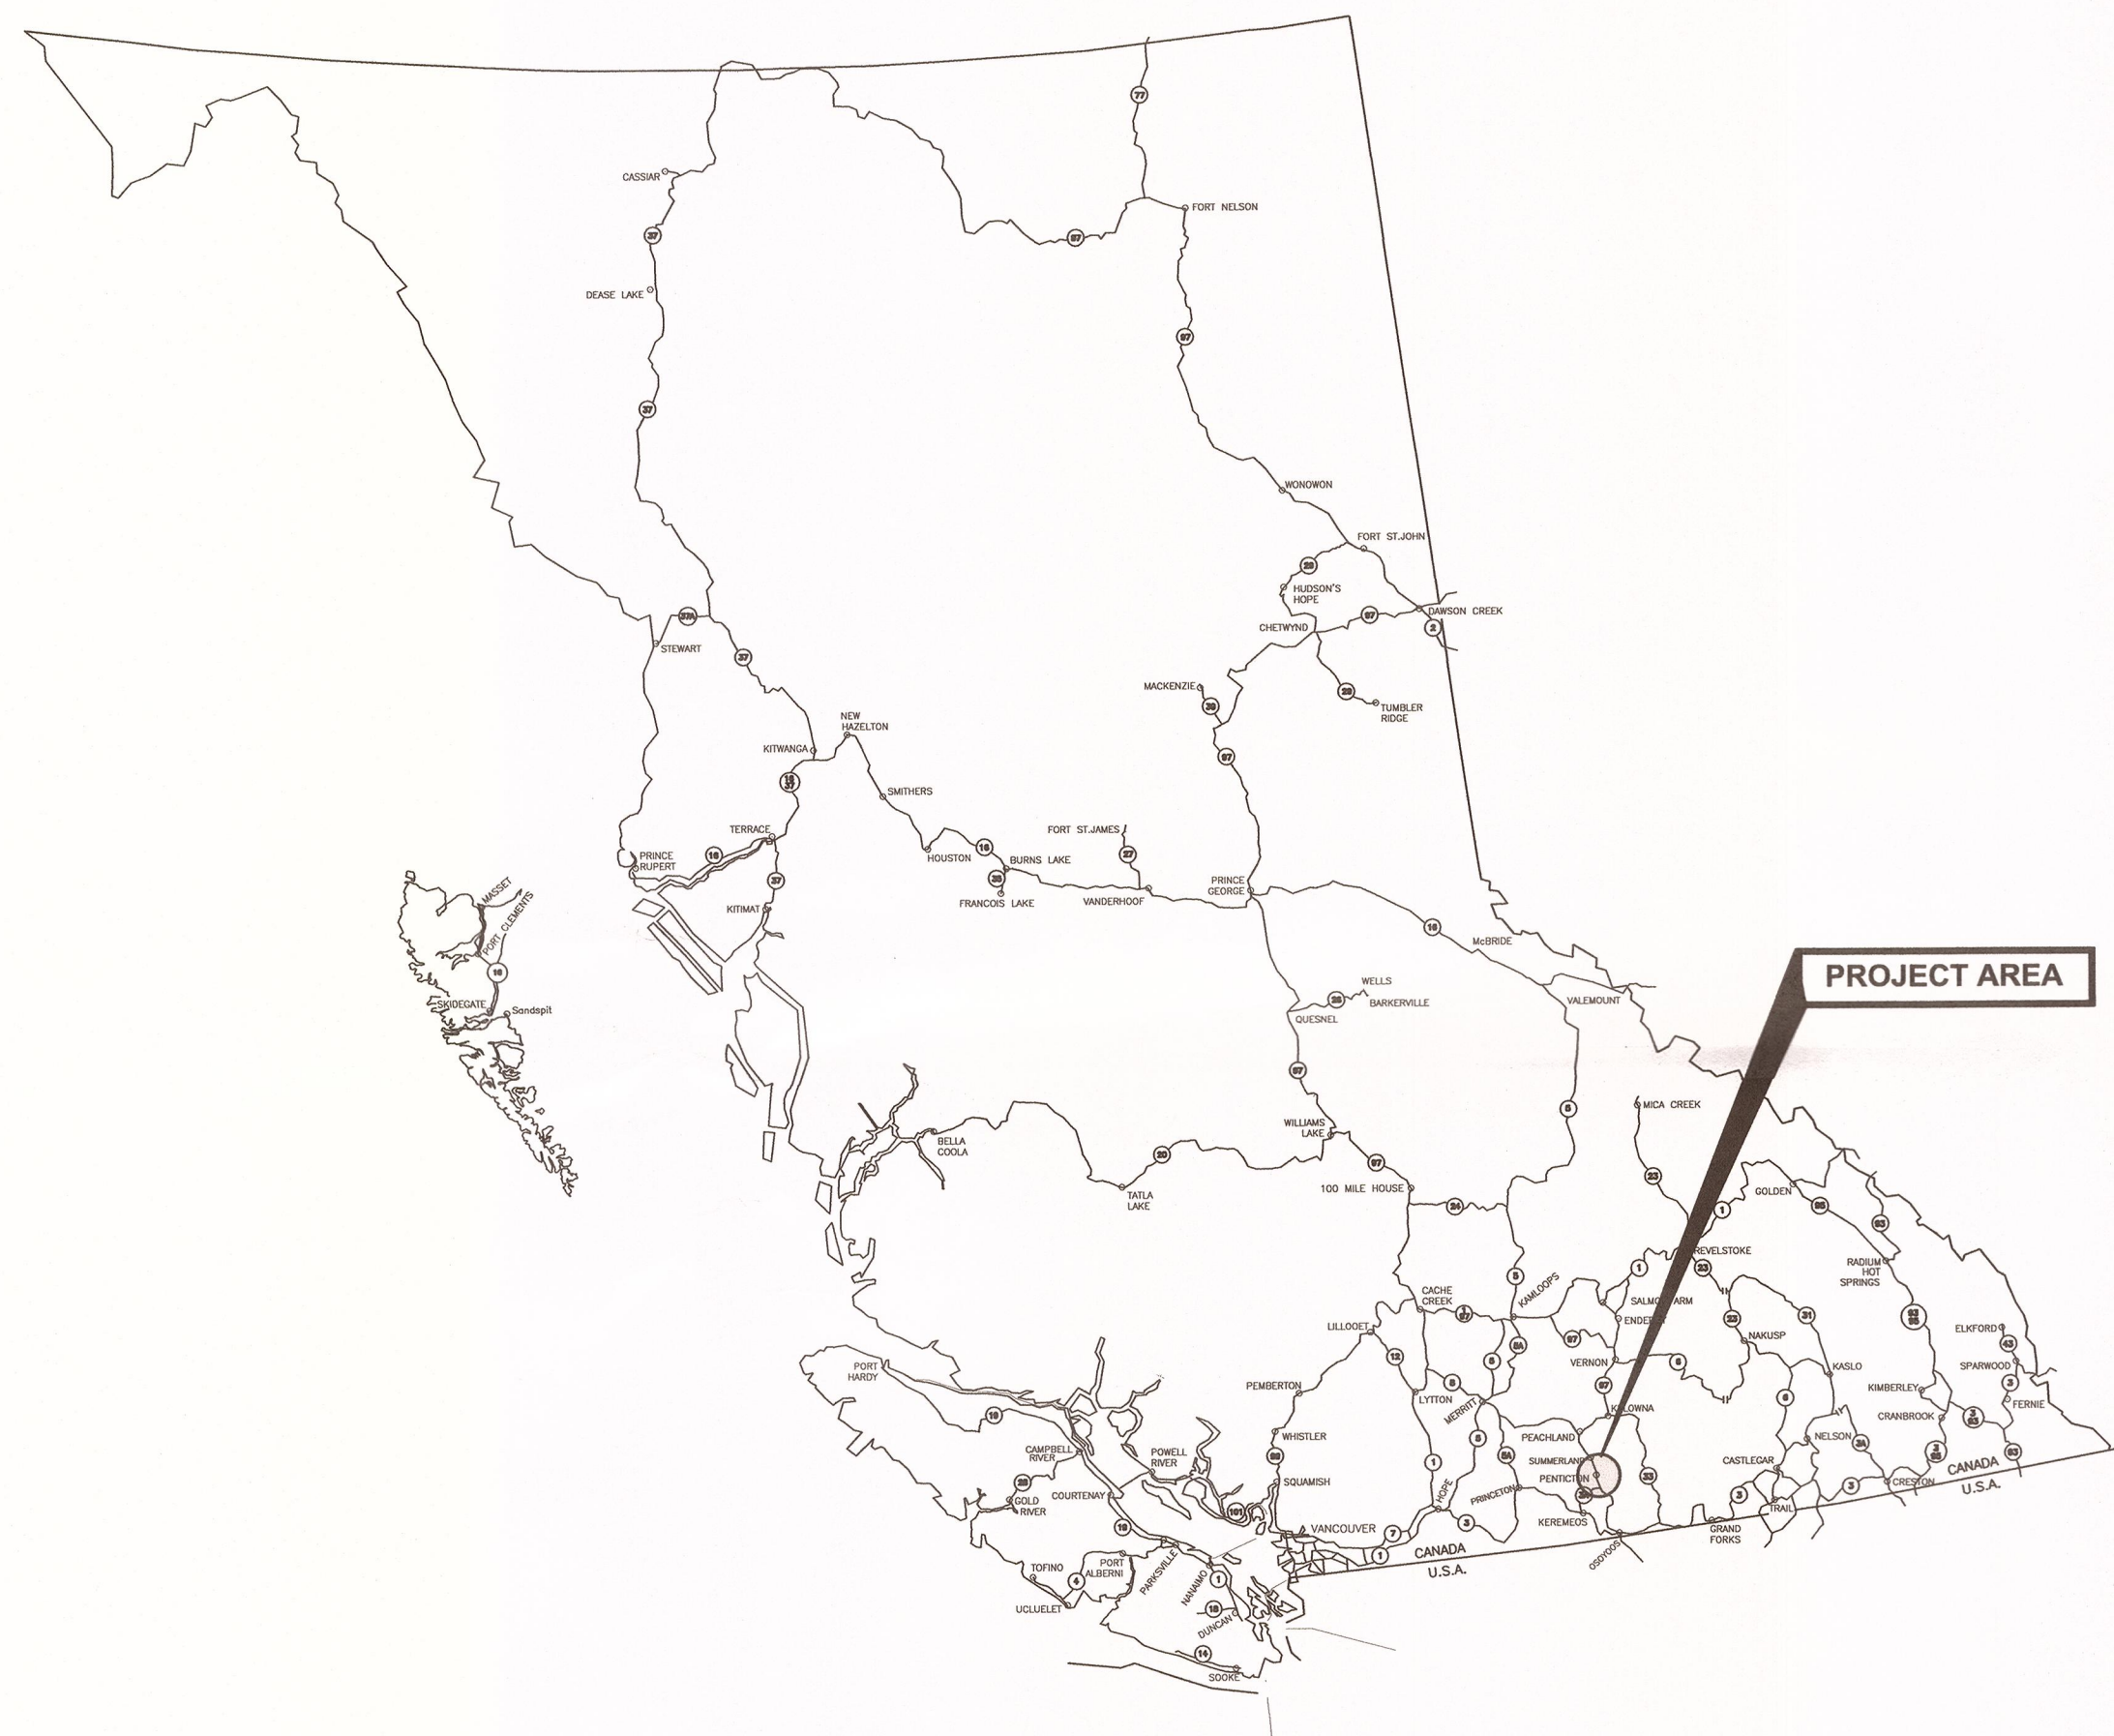

LOCATION PLAN  
NTS

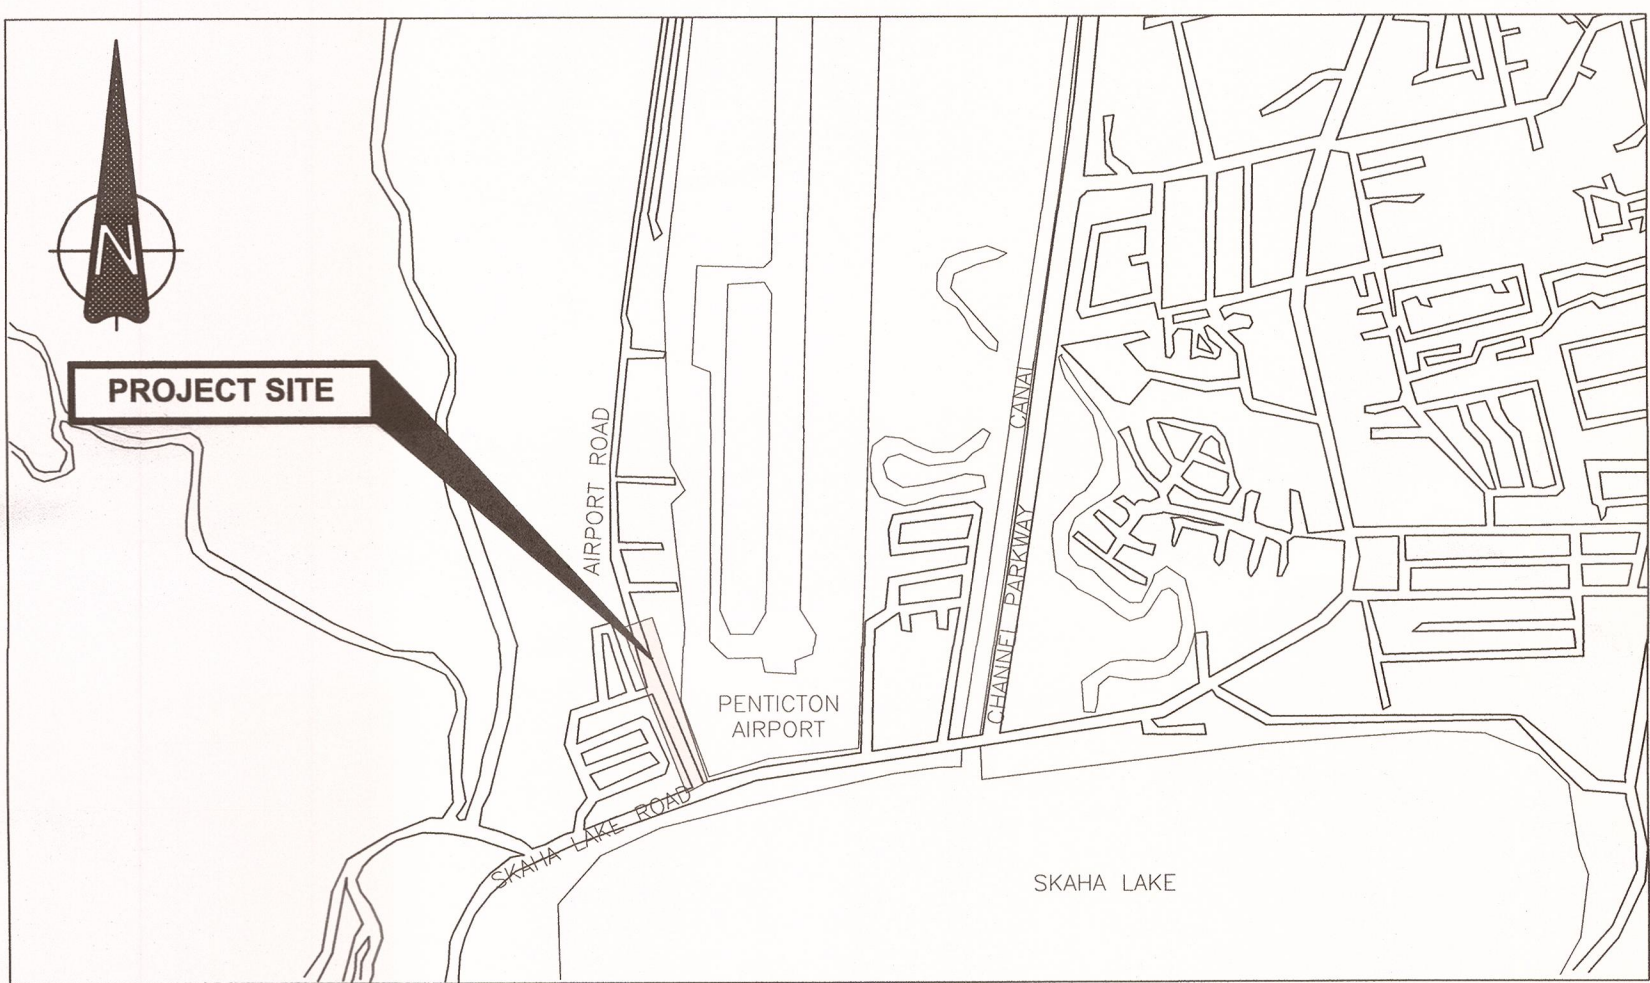


KEY PLAN  
NTS

LEGEND	
EXISTING	PROPOSED
	ASPHALT PAVEMENT
	SANITARY SEWER
	STORM SEWER
	WATERMAIN/VALVE/METER
	BLOWOFF/HYDRANT
	GAS MAIN/VALVE
	CULVERT
	DRYWELL
	RIP-RAP
	MANHOLE
	OVERFLOW DEVICE
	CATCH BASIN
	TREELINE
	TREES
	UTILITY POLE
	STREET LIGHT
	JUNCTION BOX
	ROAD SIGN
	FENCE
	BOLLARD
	PULLBOX
	ELECTRICAL
	TELEPHONE
	CABLE
	FORCEMAIN
	ELEVATIONS
	SIGNAL POLE

HDPE - HIGH DENSITY POLY-ETHYLENE  
PIPEPVC - POLYVINYL CHLORIDE PIPE  
HDD - HORIZONTAL DIRECTIONAL DRILLING  
F/M - FORCEMAIN  
SAN - SANITARY  
WTR - WATER

**BENCHMARK**  
CONTROL MONUMENT: #79H2033  
LOCATION: ALONG EAST BANK OF OKANAGAN  
RIVER CHANNEL AND SET ABOUT 415  
METRES NORTH OF SKAHA LAKE ROAD

DRAWING INDEX		
SHEET No.	DRAWING NUMBER	DESCRIPTION
01	R.070556.101-001	COVER SHEET / LOCATION PLAN & DRAWING INDEX
02	R.070556.101-101	PLAN PROFILE 0+000 - 0+240
03	R.070556.101-102	PLAN PROFILE 0+240 - 0+396
04	R.070556.101-103	DETAILS

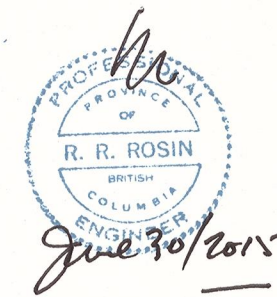

6		
5		
4	TENDER SUBMISSION	15/06/30
3	100% DETAILED DESIGN	15/01/21
2	99% DETAILED DESIGN	14/10/30
1	PRELIMINARY DESIGN	14/09/30
Revision/ Révision	Description/Description	Date/Date

Client/client  
**PUBLIC WORKS &  
GOVERNMENT SERVICES  
CANADA (PWGSC)**

Project title/Titre du projet  
**PENTICTON AIRPORT**  
**AIRPORT ROAD FORCEMAIN  
REPLACEMENT**

Consultant Signature Only  
R. ROSIN  
Designed by/Concept par  
R. ROSIN / D. PALOMBI  
Drawn by/Dessiné par  
D. PALOMBI  
PWGSC Project Manager/Administrateur de Projets TPSCG  
MONIQUE SIMARD

Regional Manager, Architectural and Engineering Services  
Gestionnaire régional, Services d'architectural et de génie, TPSCG  
REGIONAL MANAGER AES

Drawing title/Titre du dessin  
**COVER SHEET / LOCATION PLAN  
& DRAWING INDEX**


Project No./No. du projet <b>R.070556.101</b>	Sheet/Fauille <b>01</b> OF 04	Revision no./ La Révision no. <b>4</b>
---	-------------------------------------	---








H:\projects\31251 Penticton Airport Road Forcemain\02\_CADD\20\_Drafting\R.070556.101-101 (Plan).dwg

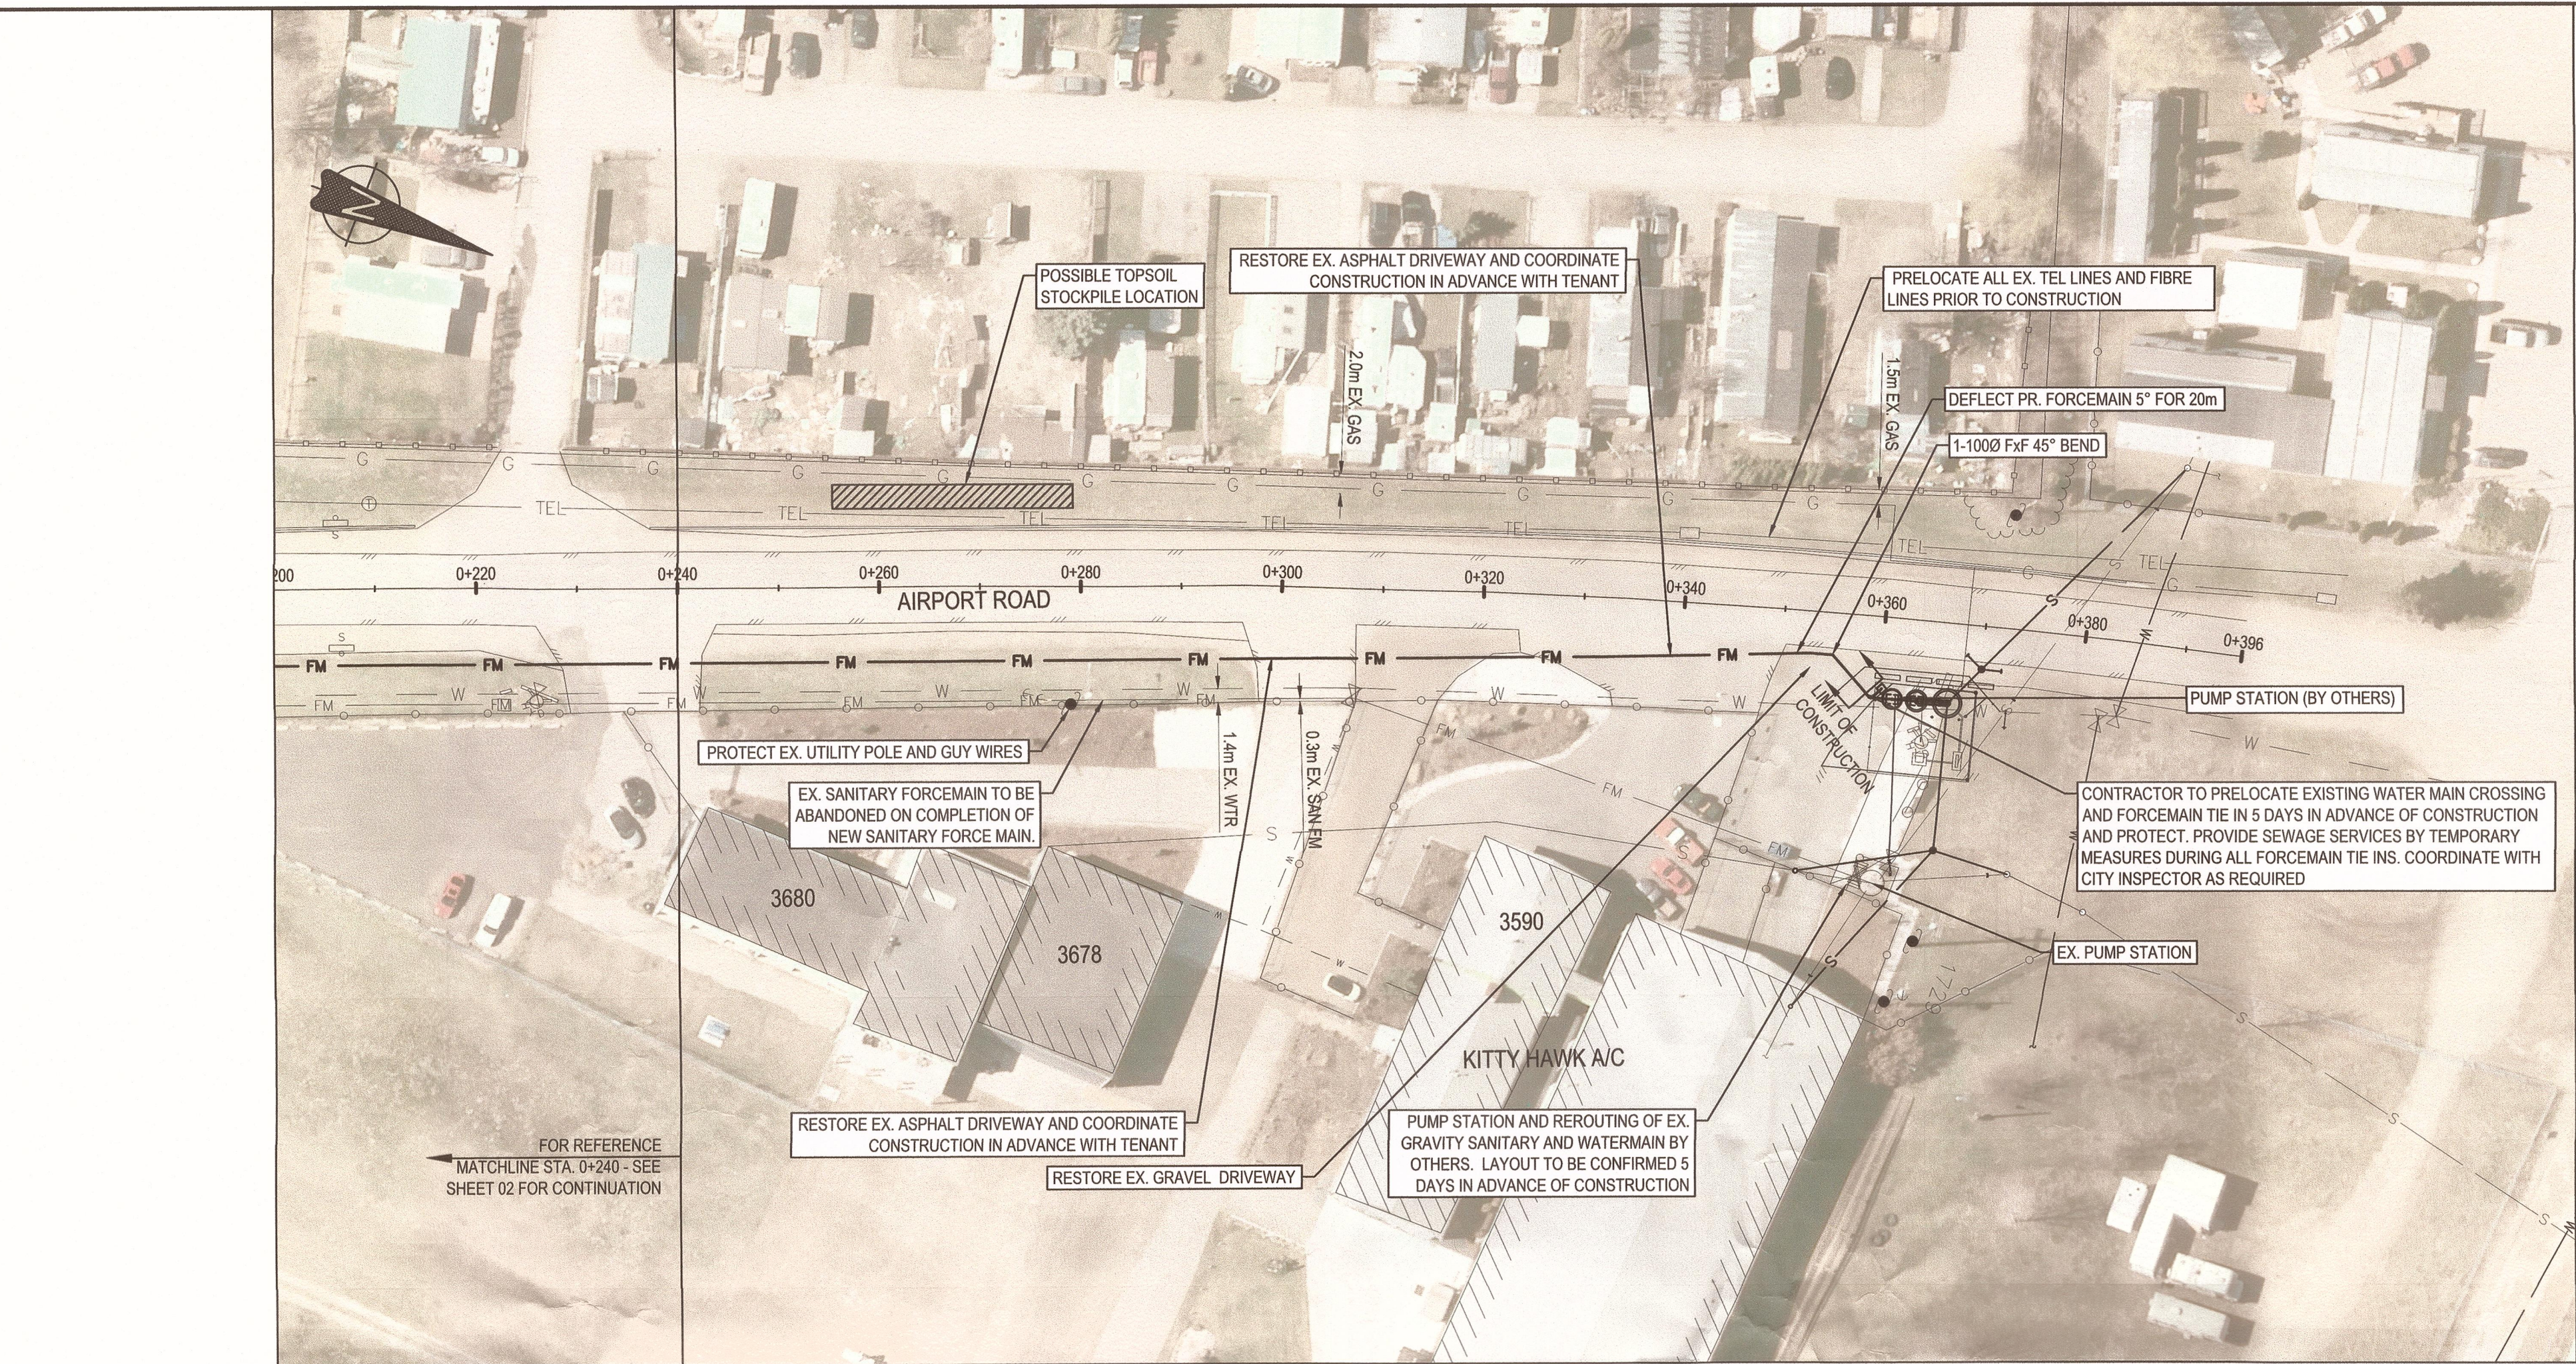

PLAN  
SCALE HORZ: 1:500

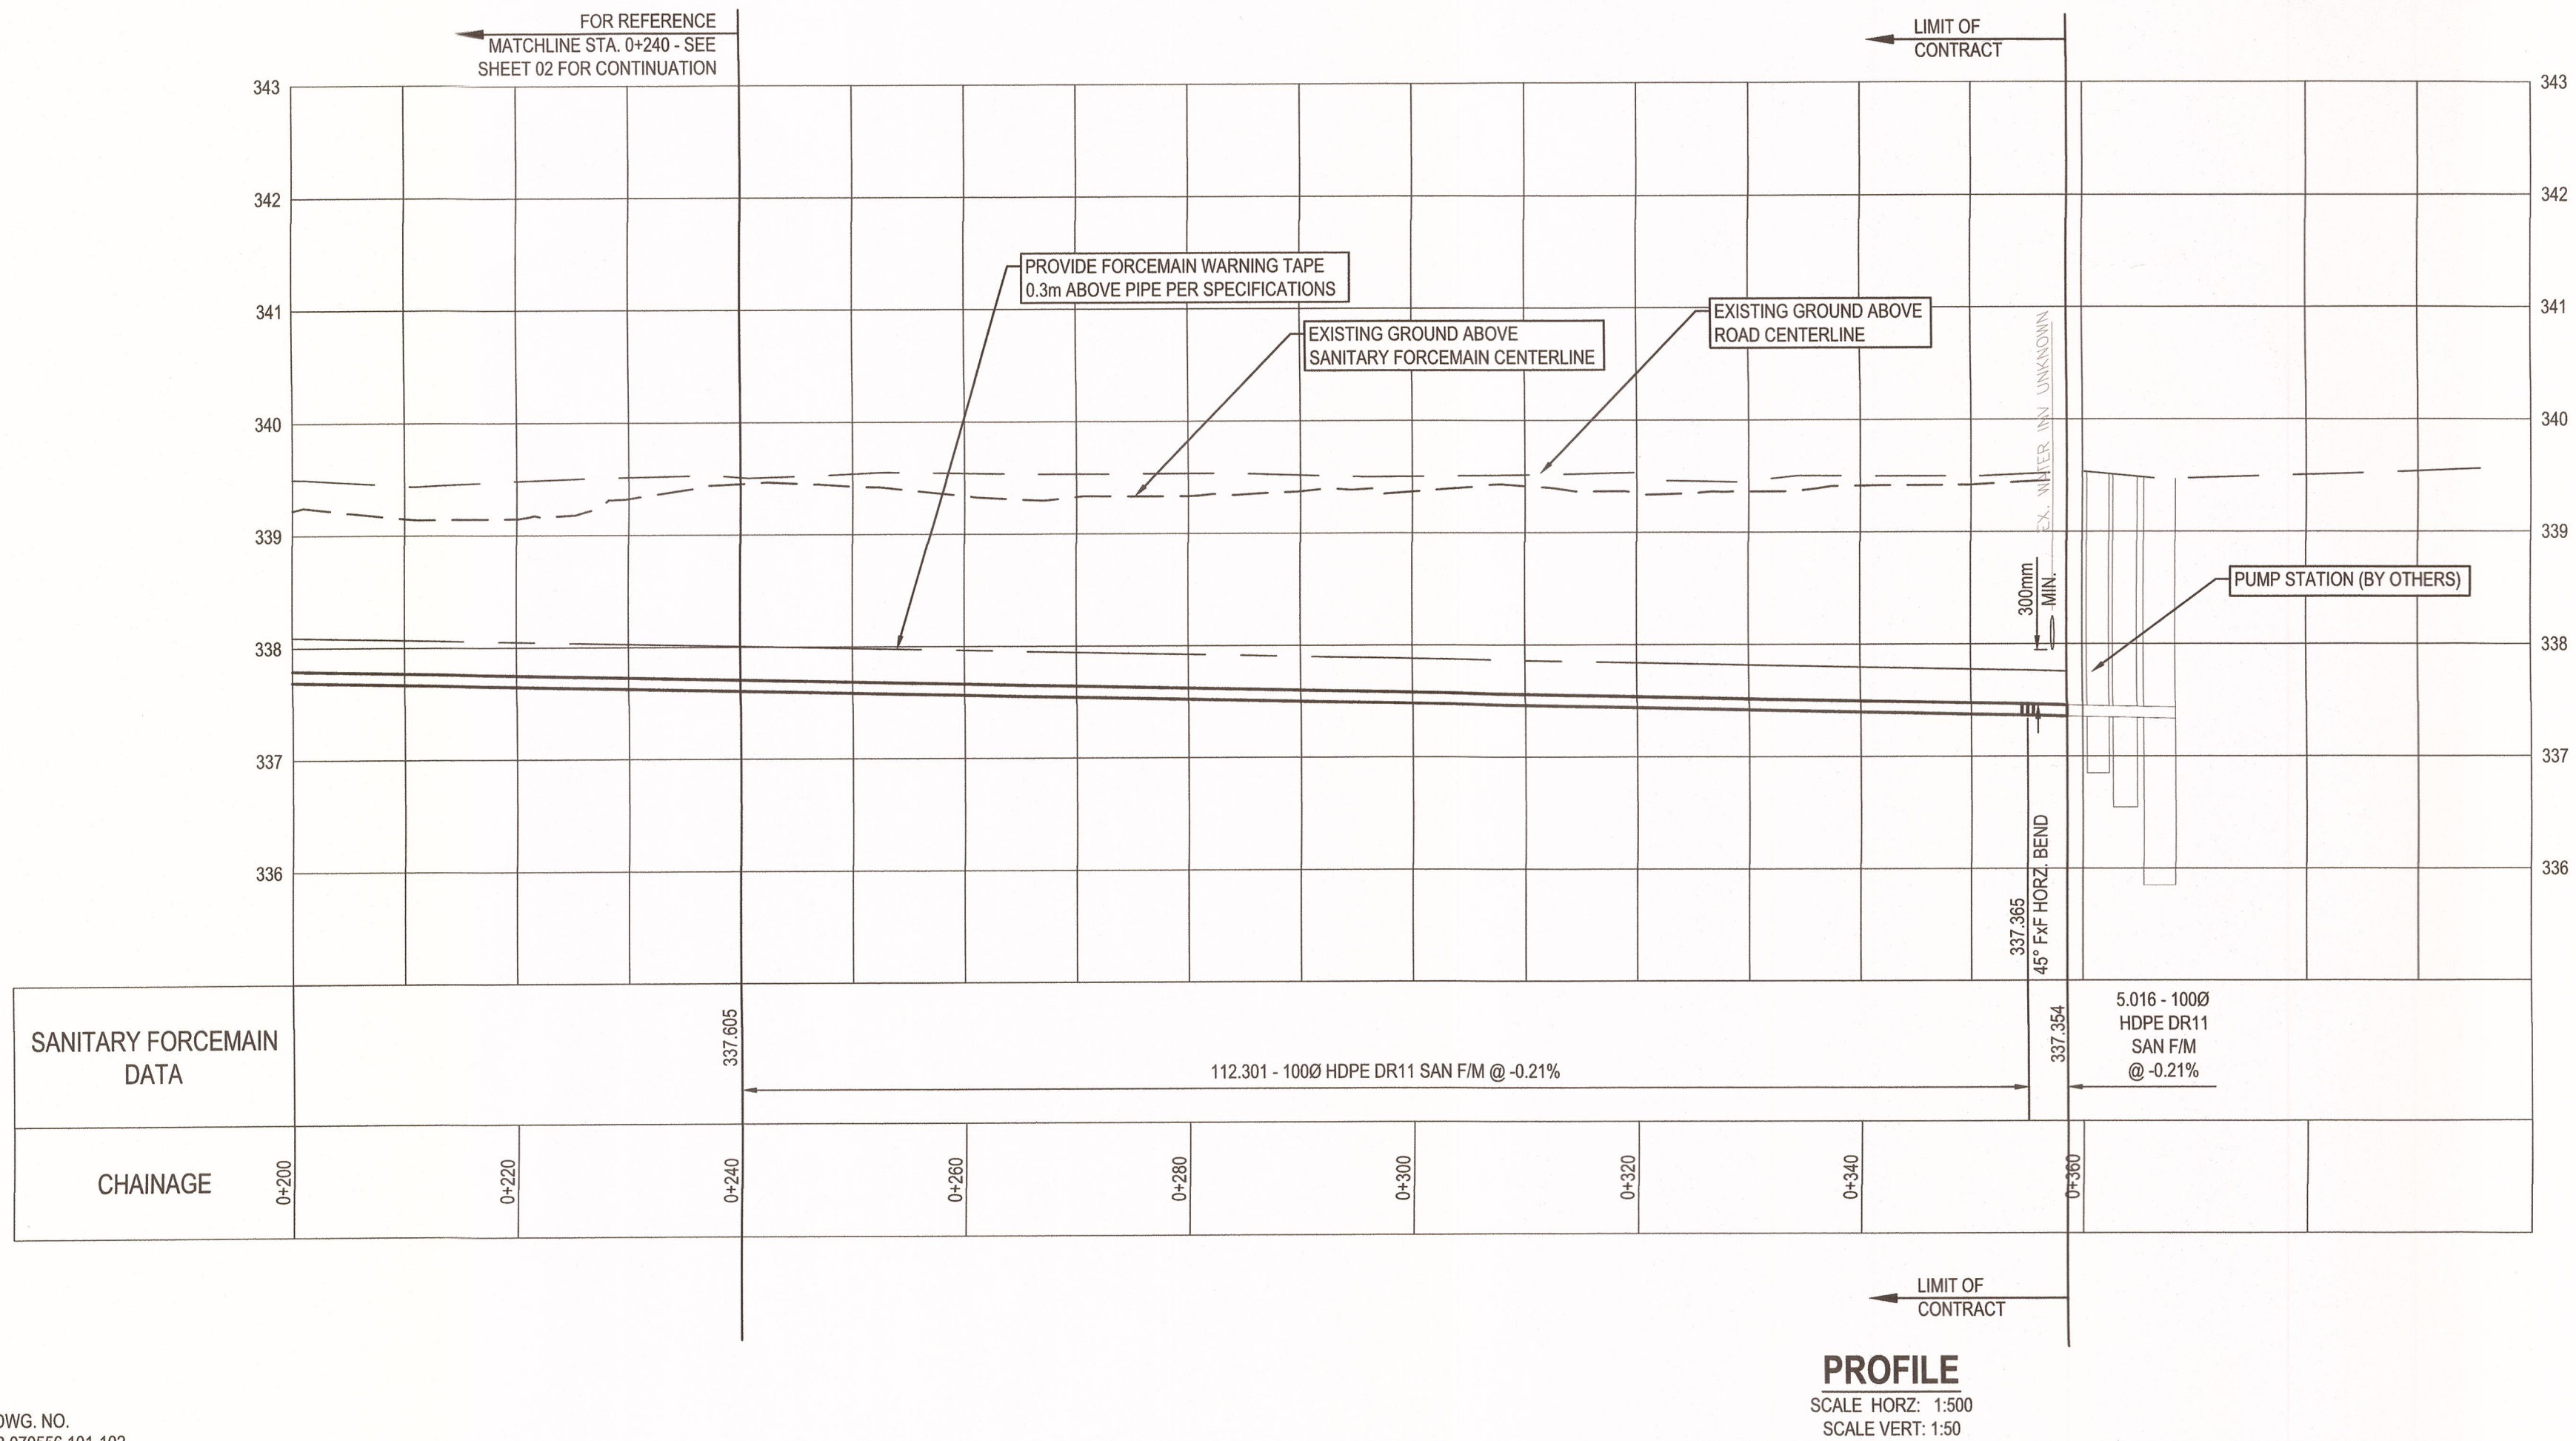


PROFILE  
SCALE HORZ: 1:500  
SCALE VERT: 1:50

DWG. NO.  
R.070556.101-102

 
PWGSC - A1 - 841X594

0 10 20 30 40 50 60 70 80 90 100mm

- NOTES:
1. CONTRACTOR IS TO FIELD CONFIRM ALL UTILITY CROSSINGS PRIOR TO CONSTRUCTION. NO PAYMENT WILL BE MADE FOR RE-GRADING OR REPLACING UTILITIES THAT ARE FOUND TO BE IN CONFLICT WHERE PRE-LOCATING WAS NOT PERFORMED BY THE CONTRACTOR.
  2. ALL EXISTING UTILITIES ARE SHOWN ACCORDING TO AVAILABLE RECORD DRAWINGS. NO RESPONSIBILITY IS IMPLIED OR ASSUMED BY PWGSC OR ISL AS TO AS FOUND LOCATION. THE CONTRACTOR SHALL LOCATE ALL EXISTING UTILITIES PRIOR TO CONSTRUCTION, INCLUDING UNDERGROUND POWER AND TELEPHONE SERVICE DUCTS AND SHALL NOTIFY THE DEPARTMENT REPRESENTATIVE OF ANY CONFLICTS A MINIMUM OF 5 DAYS PRIOR TO CONSTRUCTION. ANY ADDITIONAL WORK REQUIRED AS A RESULT OF FAILING TO PRE-LOCATE KNOWN OR POTENTIAL CONFLICTS WILL BE COMPLETED AT THE CONTRACTOR'S EXPENSE.
  3. PROVIDE TEMPORARY PROTECTION OF ALL EXISTING UNDERGROUND SERVICES DURING CONSTRUCTION. PROVIDE ADVANCE LOCATES OF EXISTING FORCEMAIN TO REDUCE RISK OF SERVICE DISRUPTION.



Public Works and  
Government Services  
Canada





Travaux publics et  
Services gouvernementaux  
Canada

REAL PROPERTY SERVICES

Pacific Region

SERVICES IMMOBILIERS

Région de Pacifique

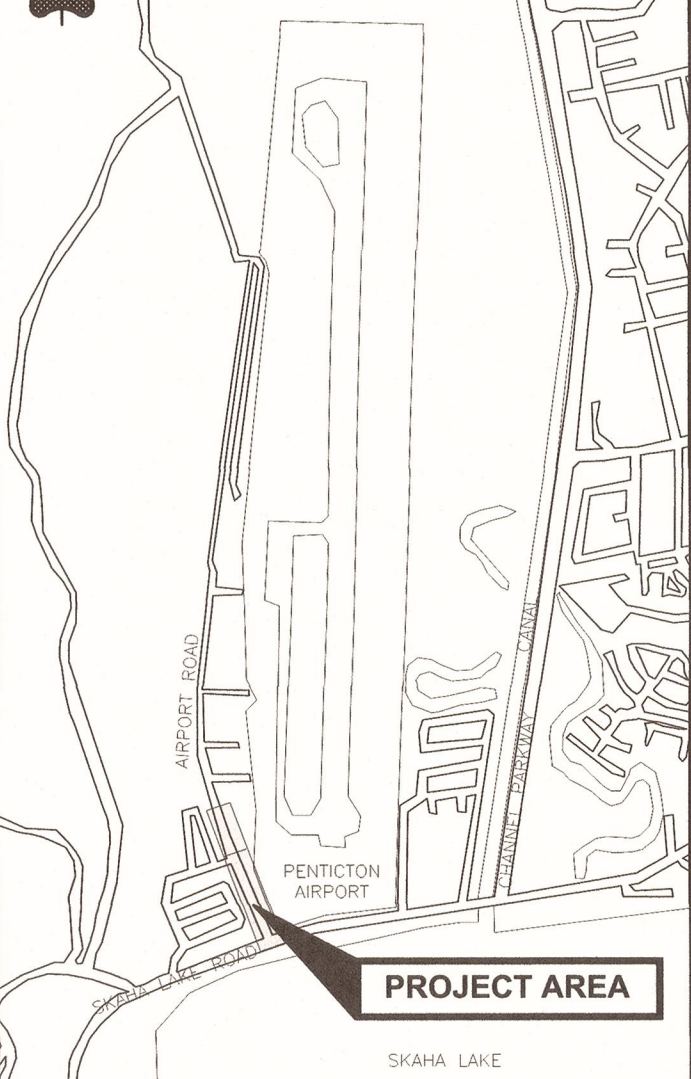

PROJECT AREA

KEY PLAN

SCALE: NTS

Revision/Revisions	Description/Description	Date/Date
6		
5		
4	TENDER SUBMISSION	15/06/30
3	100% DETAILED DESIGN	15/01/21
2	99% DETAILED DESIGN	14/10/30
1	PRELIMINARY DESIGN	14/09/30

Cliant/client

PUBLIC WORKS &  
GOVERNMENT SERVICES  
CANADA (PWGSC)

Project title/Titre du projet

PENTICTON AIRPORT

AIRPORT ROAD FORCEMAIN  
REPLACEMENT

Consultant Signature Only

R. ROSIN

Designed by/Concept par

R. ROSIN / D. PALOMBI

Drawn by/Dessiné par

D. PALOMBI

PWGSC Project Manager/Administrateur de Projets TPSCG

MONIQUE SIMARD

Regional Manager, Architectural and Engineering Services

Gestionnaire régionale, Services d'architectural et de génie, TPSCG

REGIONAL MANAGER AES

Drawing title/Titre du dessin

SANITARY FORCEMAIN

STA. 0+240 TO STA. 0+396

PLAN AND PROFILE

Project No./No. du projet

R.070556.101


Sheet/Feuille

03

OF 04

Revision no./La révision

4

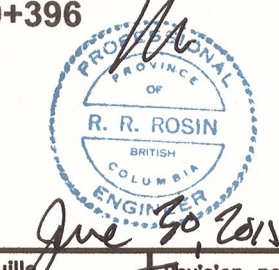

*June 20, 2025*

DMSXXXXXX



